

S.R. 405 FIRE STATION

TITUSVILLE, BREVARD COUNTY

FLORIDA

LOT COVERAGE CALC:

	FT ²	% SITE	AC.
BUILDING AREA	3600		
PAVED AREA	12,110		
GREEN AREA			
TOTAL LOT AREA			
ZONING			
ADJACENT ZONING			

1" RAINFALL CALC:

14,710 FT² x 1" = 1000 FT³ NEED FOR RETENTION

THESE PLANS ARE THE PROPERTY OF THE ARCHITECT AND MAY NOT BE REPRODUCED OR COPIED WITHOUT HIS CONSENT.

CONSTRUCTION OF THIS BUILDING WILL NOT BE UNDER THE SUPERVISION OF THE ARCHITECT. HE THEREFORE ASSUMES NO RESPONSIBILITY FOR FAILURES DUE TO CHANGES OR DEVIATIONS FROM THE PLANS AS SEALED.

SCHEDULE OF DRAWINGS


- 1 SITE PLAN & COVER SHEET
- 2 FLOOR & FOUNDATION PLAN & DETAILS
- 3 ELEVATIONS & DETAILS
- 4 ELECTRICAL & LIGHTING PLAN
- 5 AIR-CONDITIONING & PLUMBING PLAN

ALL WORK TO CONFORM TO APPLICABLE PROVISIONS OF LOCAL, STATE & NATIONAL CODES & ORDINANCES

site plan

LEGAL DESCRIPTION:

SCALE 1" = 20'

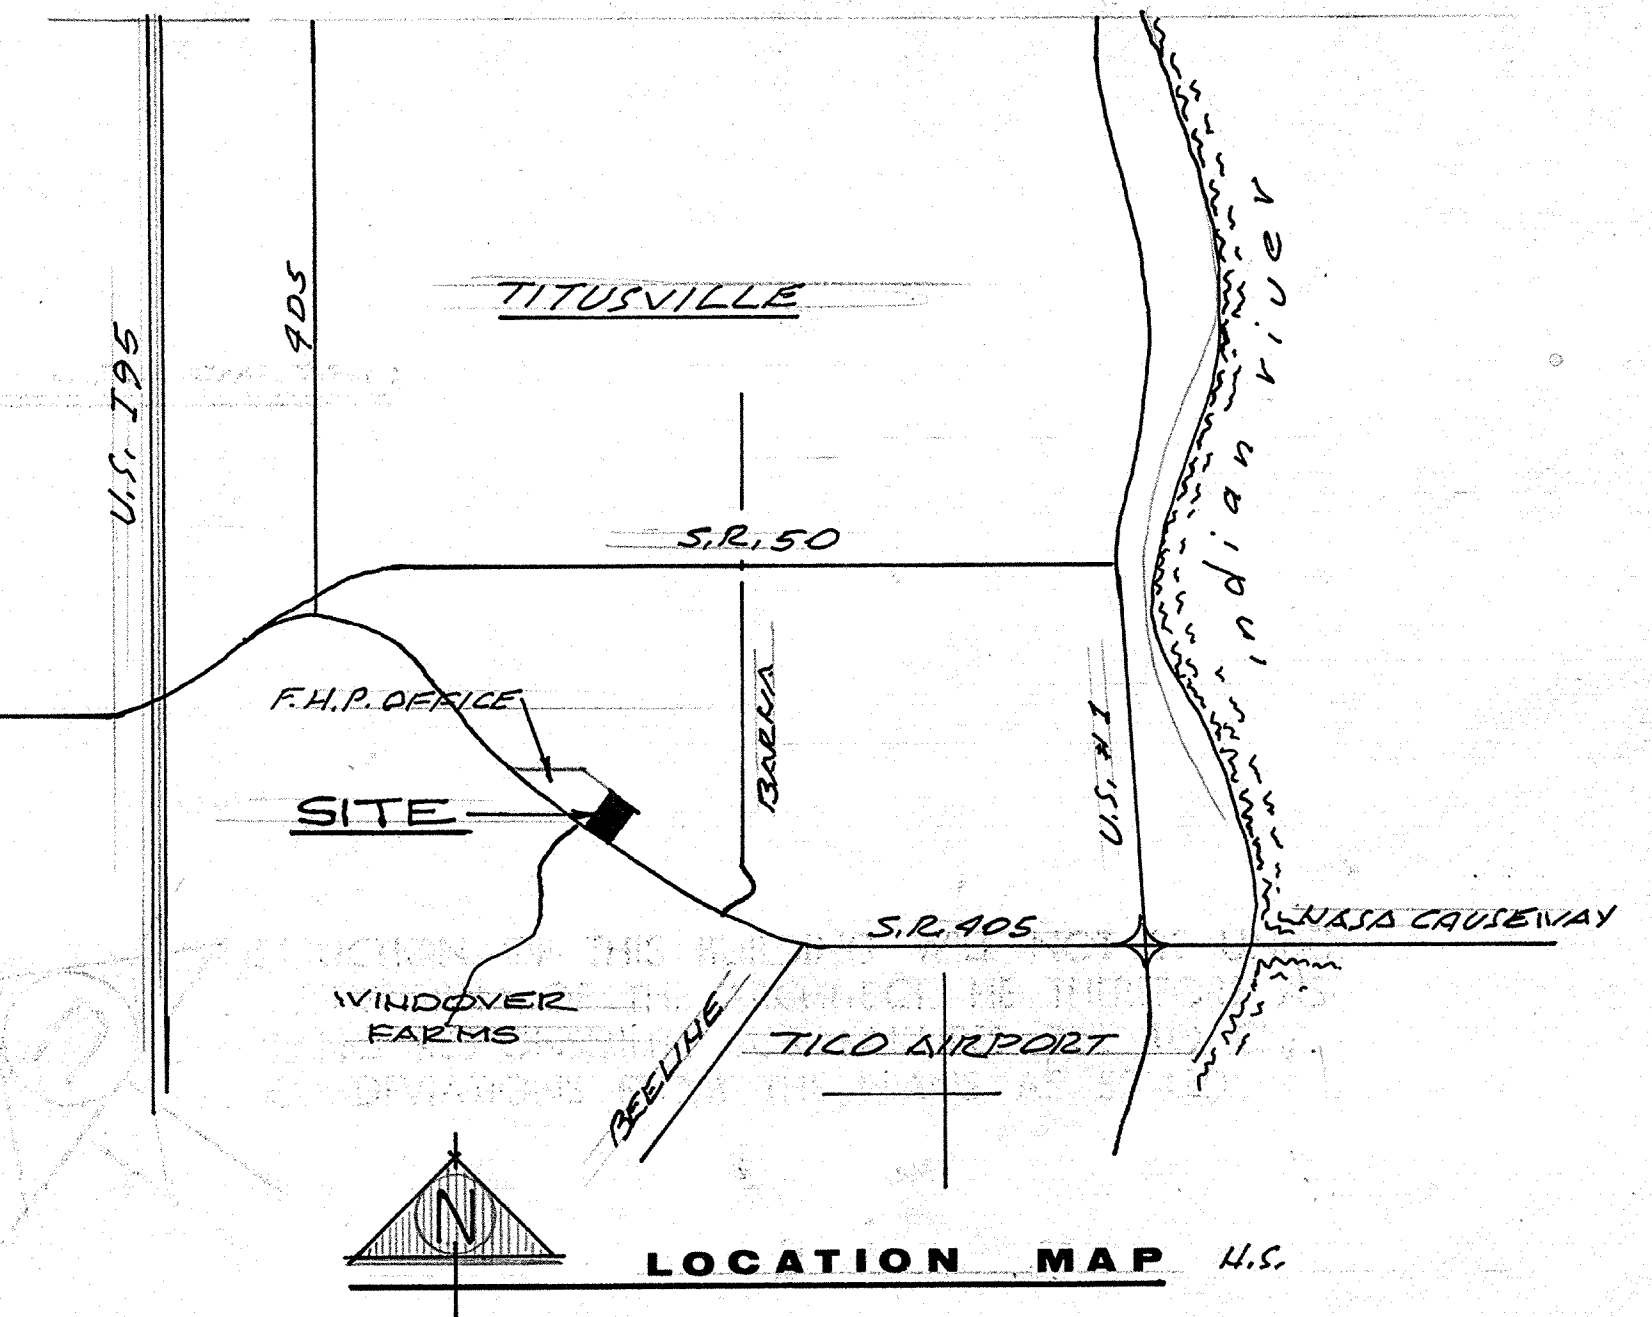

DAVID M. PUTNAM • ARCHITECT

355 PINE STREET
TITUSVILLE, FLORIDA • TEL. 267-6915

SITE PLAN & COVER SHEET

S.R. 405 FIRE STATION
TITUSVILLE, BREVARD COUNTY, FLORIDA

JOB NO. 01-70
DRAWN KCH

CHECK
DATE 3 Nov 1970
REVISED

SHEET NUMBER

1

OF 5 SHEETS