

NOTES:

- THIS IS NOT A BOUNDARY SURVEY.
- DATA SHOWN HEREON IS BASED ON THE FLORIDA DEPARTMENT OF TRANSPORTATION (FDOT) FLORIDA PERMANENT REFERENCE NETWORK (FPRN), STATE PLANE COORDINATE SYSTEM EAST ZONE NORTH AMERICAN DATUM (NAD) OF 1983 WITH 2011 ADJUSTMENT.
- THIS ITEM HAS BEEN ELECTRONICALLY SIGNED AND SEALED BY JAMES A. SHABLUK, PSM #7027 ON THE DATE/TIME STAMP SHOWN USING A DIGITAL SIGNATURE. PRINTED COPIES OF THIS DOCUMENT ARE NOT CONSIDERED SIGNED AND SEALED AND THE SIGNATURE MUST BE VERIFIED ON ANY ELECTRONIC COPIES.
- THIS SURVEY WAS PERFORMED FOR THE SOLE AND EXCLUSIVE BENEFIT OF THE ENTITIES LISTED HEREON AND SHALL NOT BE RELIED UPON BY ANY OTHER ENTITY OR INDIVIDUAL WHOMSOEVER.
- THERE MAY BE ENVIRONMENTAL ISSUES AND/OR OTHER MATTERS REGULATED BY VARIOUS DEPARTMENTS OF FEDERAL, STATE OR LOCAL GOVERNMENTS AFFECTING THE SUBJECT PROPERTY NOT SHOWN ON THIS SURVEY.
- NO UNDERGROUND UTILITIES WERE LOCATED UNLESS SHOWN HEREON.
- LAST DATE IN FIELD: 04-21-2025.

FENCE AS-BUILT POINTS			
POINT NO.	NORTHING	EASTING	ELEVATION
12	1417658.69	750375.70	29.11
13	1417679.64	750409.76	29.17
14	1417703.76	750449.26	28.96
15	1417698.37	750472.23	29.06
16	1417701.60	750479.56	29.32
17	1417680.40	750489.23	29.32
21	1417695.59	750525.29	29.40
22	1417684.19	750546.19	28.96
27	1417659.18	750565.30	29.25
31	1417634.55	750584.33	29.13
32	1417632.24	750610.99	29.14
33	1417628.95	750653.61	29.25
34	1417672.38	750657.98	29.28
35	1417706.32	750661.14	28.67
36	1417710.45	750661.63	28.45


FENCE AS-BUILT POINTS			
POINT NO.	NORTHING	EASTING	ELEVATION
37	1417708.37	750661.55	28.64
40	1417733.89	750664.01	27.87
41	1418152.51	750697.27	27.24
46	1418208.64	750761.76	27.78
47	1418253.70	750731.76	27.13
48	1418292.44	750705.75	27.62
49	1418330.96	750679.74	26.75
51	1418333.19	750633.57	27.53
52	1418335.71	750557.36	27.67
55	1418328.94	750543.52	27.51
56	1418321.68	750510.62	27.36
57	1418313.96	750475.08	27.10
58	1418326.22	750444.61	27.01
59	1418337.44	750417.01	27.02
60	1418379.09	750403.60	26.44

FENCE AS-BUILT POINTS			
POINT NO.	NORTHING	EASTING	ELEVATION
61	1418429.16	750387.71	26.82
62	1418510.50	750416.26	26.95
63	1418586.00	750442.87	26.99
64	1418649.12	750464.83	27.37
67	1418692.43	750447.50	27.76
68	1418698.38	750378.60	28.06
69	1418704.71	750256.79	27.02
70	1418707.78	750254.61	27.54
71	1418590.82	750247.71	27.56
72	1418467.96	750240.62	26.32
73	1418445.75	750238.34	29.11
82	1418320.02	750033.53	26.59
83	1418287.29	750021.06	26.42
84	1418262.01	750011.58	26.59
85	1418267.17	749970.16	26.34

FENCE AS-BUILT POINTS			
POINT NO.	NORTHING	EASTING	ELEVATION
86	1418276.13	749903.17	26.00
87	1418268.97	749900.55	25.94
88	1418265.33	749898.79	25.86
91	1418267.22	749899.64	26.16
92	1418238.68	749887.56	25.36
93	1418179.44	749861.78	26.83
94	1418179.54	749796.76	26.80
104	1418179.92	749752.42	26.64
112	1418167.13	749705.51	26.63
115	1418157.43	749669.44	27.26
116	1418146.63	749613.25	26.75
117	1418126.00	749576.36	34.78
118	1418112.46	749553.65	25.87
159	1417751.18	750680.29	27.84
160	1417745.28	750773.65	27.77

FENCE AS-BUILT POINTS			
POINT NO.	NORTHING	EASTING	ELEVATION
165	1417776.28	750776.61	27.53
166	1417775.30	750790.24	27.78
170	1417810.28	750793.28	27.94
171	1417860.54	750797.47	27.54
172	1417885.65	750817.03	27.05
173	1417924.26	750818.52	26.98
174	1417946.38	750811.04	26.79
175	1417984.20	750783.60	27.00
176	1418072.13	750719.69	27.23
177	1418105.24	750699.15	27.61
613	1418178.48	750727.18	27.34

PROPOSED FENCE POINTS		
POINT NO.	NORTHING	EASTING
139	1417666.32	749465.68
140	1417386.71	749443.93
143	1417373.04	749564.83
145	1417406.90	749734.16
146	1417418.00	749859.27
148	1417503.08	750121.74
149	1417485.93	749991.71
150	1417577.06	750242.50
1002	1417508.63	749449.32
1004	1417510.69	749450.20
1005	1417556.61	749447.49

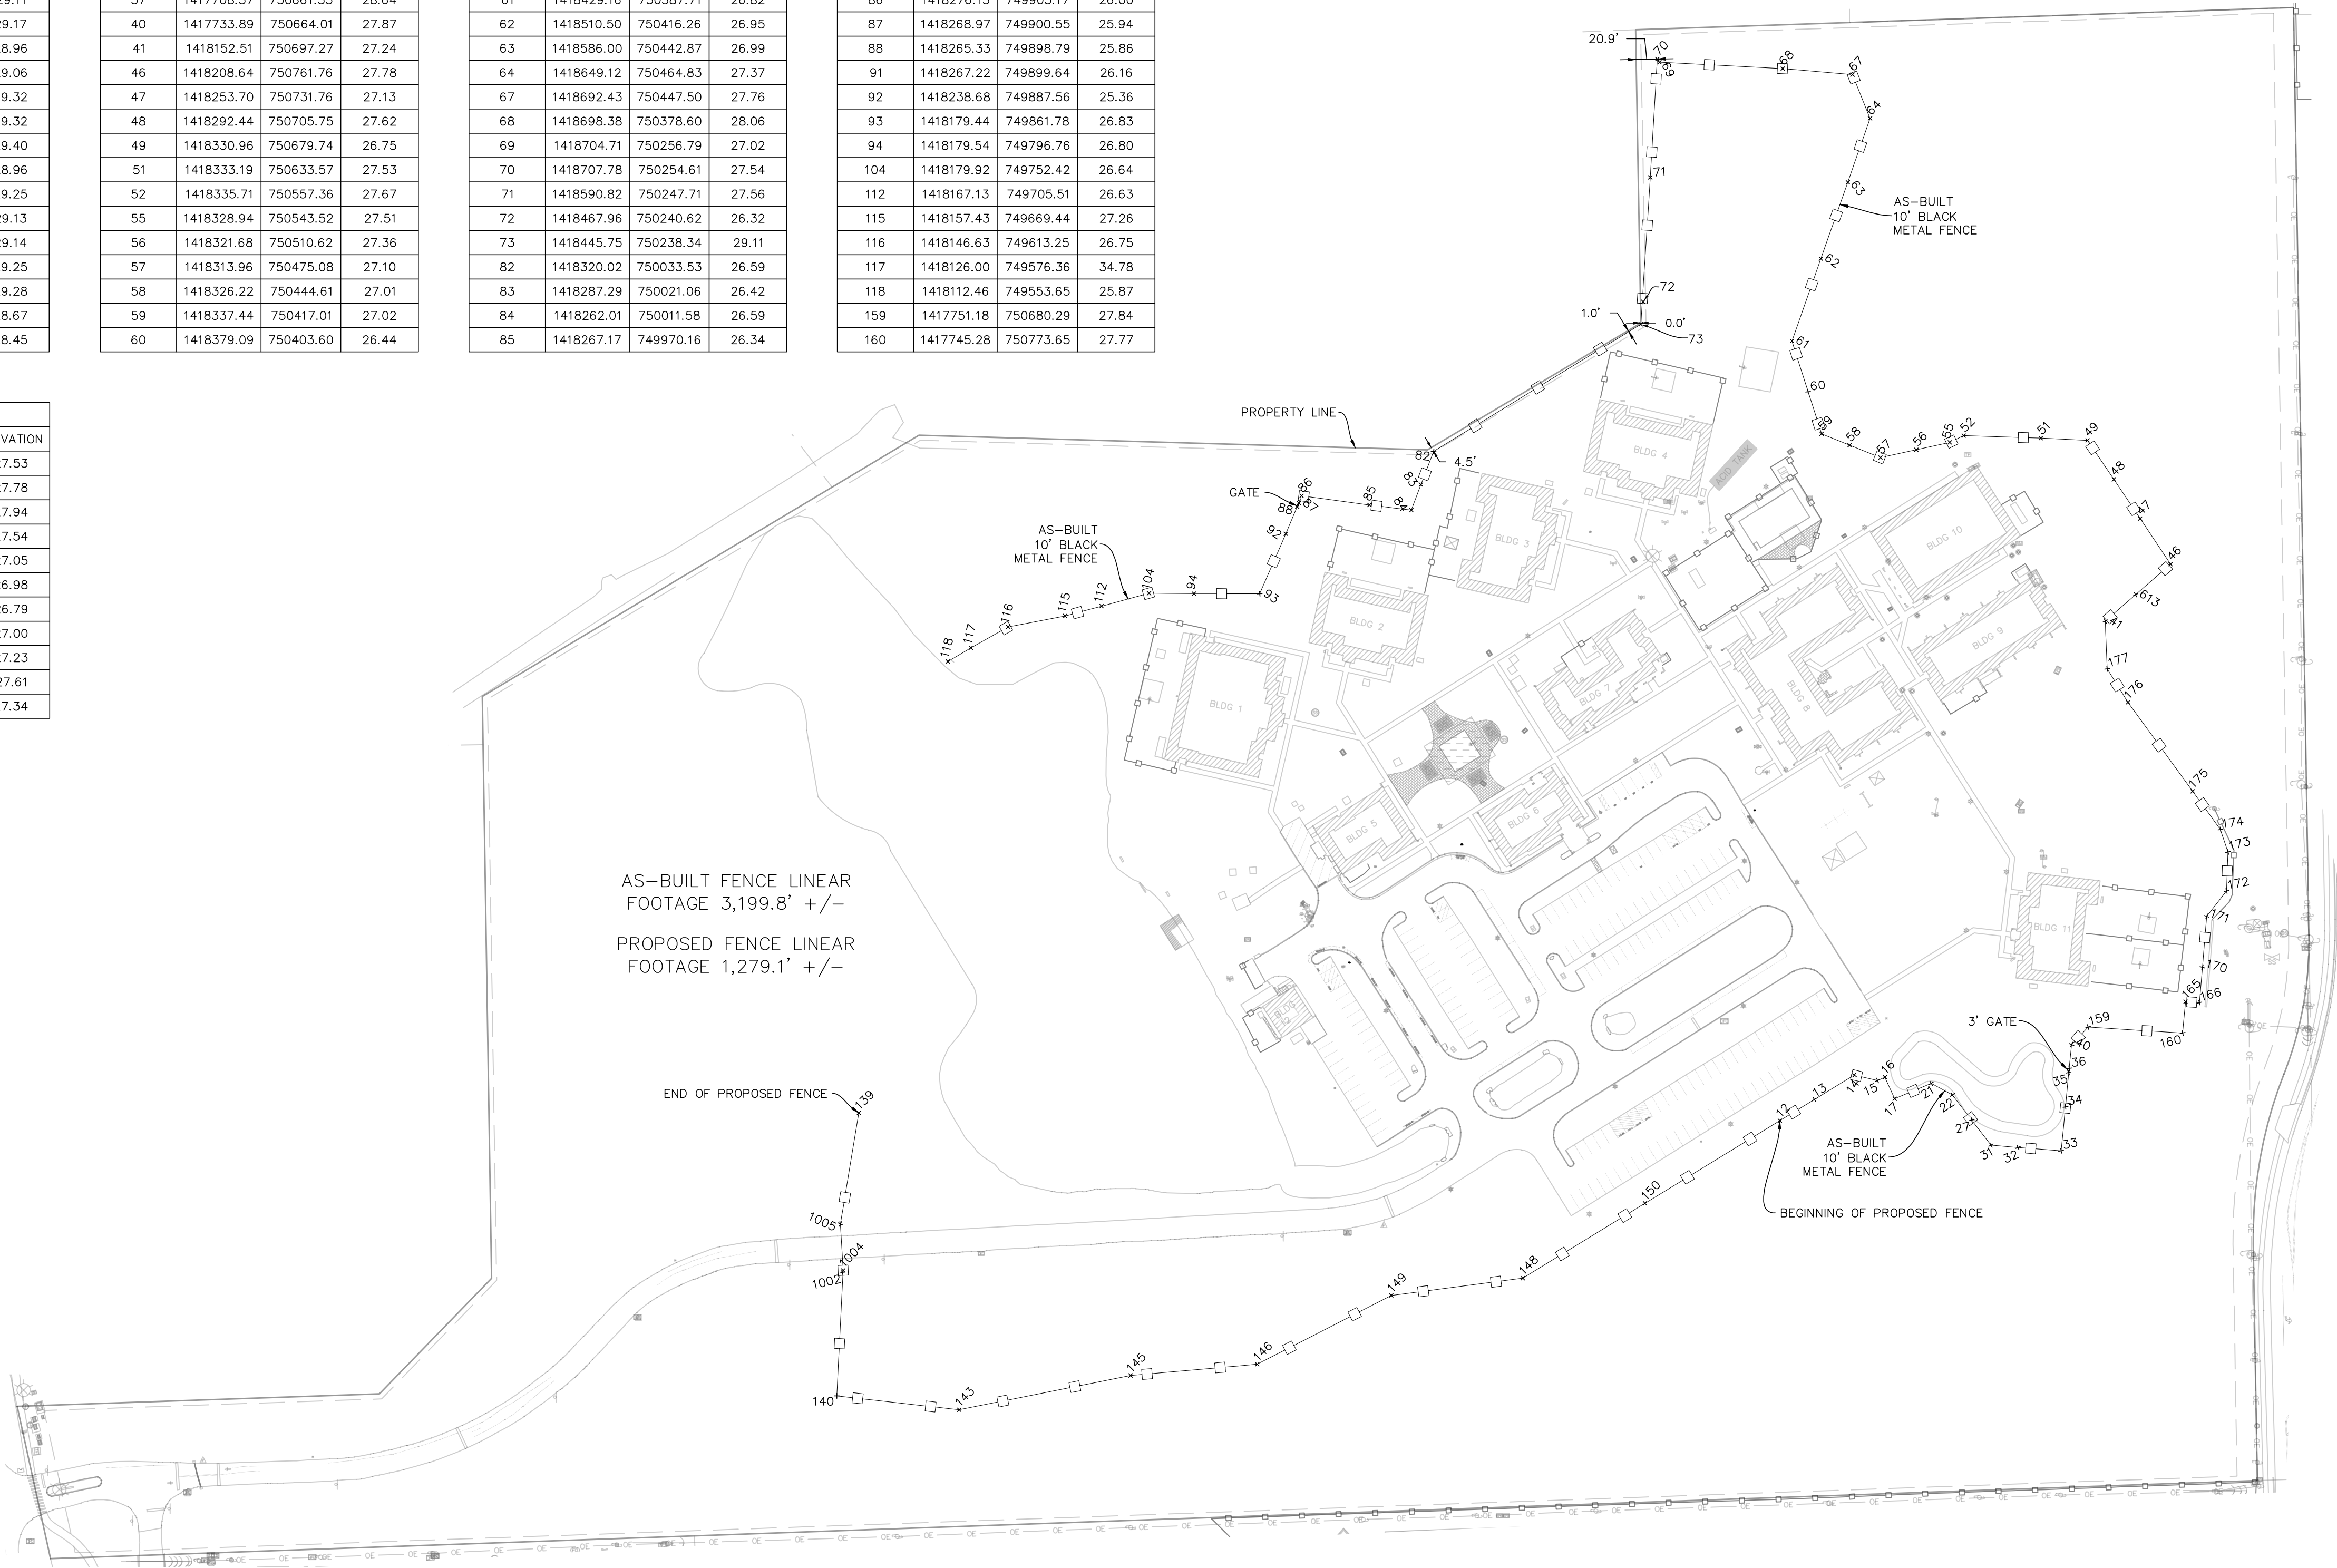

SYMBOL AND ABBREVIATION LEGEND:

- A/C

BACKFLOW PREVENTER

BASKETBALL HOOP

BOLLARD

CATCH BASIN

CLEANOUT

CONC

CONCRETE LIGHT POLE

CONCRETE POWER POLE

E

ELECTRICAL CABINET

ELECTRICAL MANHOLE

ELECTRICAL MARKER

ELECTRICAL METER

ELECTRICAL PANEL

ELECTRICAL PULL BOX

ELECTRICAL RISER

ELECTRIC JUNCTION BOX

ELECTRICAL VAULT

ESMT

EASEMENT

E

EAST/EASTING

EC

EDGE OF CONCRETE

FENCE LINE

FIBER OPTIC MARKER

FIBER OPTIC RISER

FIBER OPTIC VAULT
- FIRE DEPARTMENT CONNECTION

FORCE MAIN AIR RELEASE VALVE

GUY WIRE

IRRIGATION VALVE

LB

LICENSED BUSINESS

LS

LICENSED SURVEYOR

METAL LIGHT POLE

MITERED END SECTION

N/D

NAIL AND DISK

NATURAL GAS MARKER

NATURAL GAS METER

NATURAL GAS VALVE

N

NORTH/NORTHING

OVERHEAD ELECTRICAL LINE

PSM

PROFESSIONAL SURVEYOR AND MAPPER

RCP

RECLAIMED WATER VALVE

REINFORCED CONCRETE PIPE

SANITARY SEWER MANHOLE

SINGLE STAND SIGN

S

SOUTH

STORM DRAINAGE MANHOLE

TELECOMMUNICATION CABINET
- TELECOMMUNICATION MANHOLE

TELECOMMUNICATION VAULT

TRANSFORMER

UNKNOWN MANHOLE

UNKNOWN UTILITY RISER

VAULT


W

WOODEN POWER POLE

X/CONC

X CUT ON CONCRETE

VICINITY MAP: NOT TO SCALE

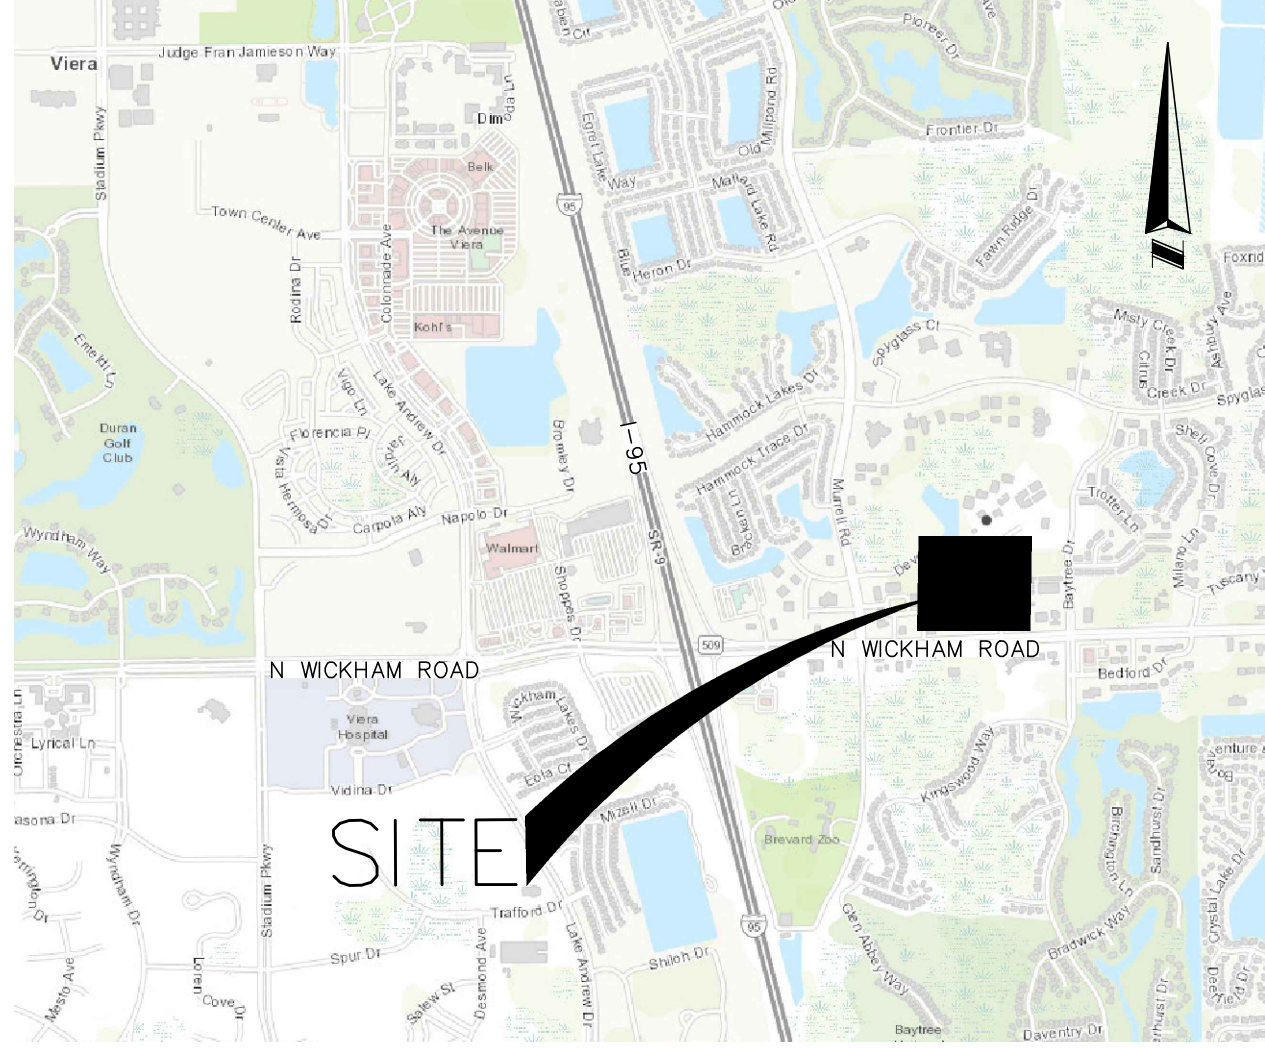

SURVEYING • MAPPING
GEOSPATIAL SERVICES
www.allen-company.com

16 EAST PLANT STREET
WINTER GARDEN, FLORIDA 34787
(407) 654-5355 FAX (407) 654-5356

AS-BUILT SURVEY
OF
DEVEREUX FENCE LAYOUT
BREVARD COUNTY, FLORIDA

FOR:
DEVEREUX ADVANCED
BEHAVIORAL HEALTH

FOR THE LICENSED BUSINESS #8827 BY:

JAMES A. SHABLUK, PSM #7027

DATE REVISIONS

JOB #: 20250066
DATE: 05/08/2025
SCALE: 1" = 100'
CALC BY: N/A
FIELD BY: LD/TS
DRAWN BY: ES/JAS
CHECKED BY: MA/JAS

SHEET 1 OF 1